

 

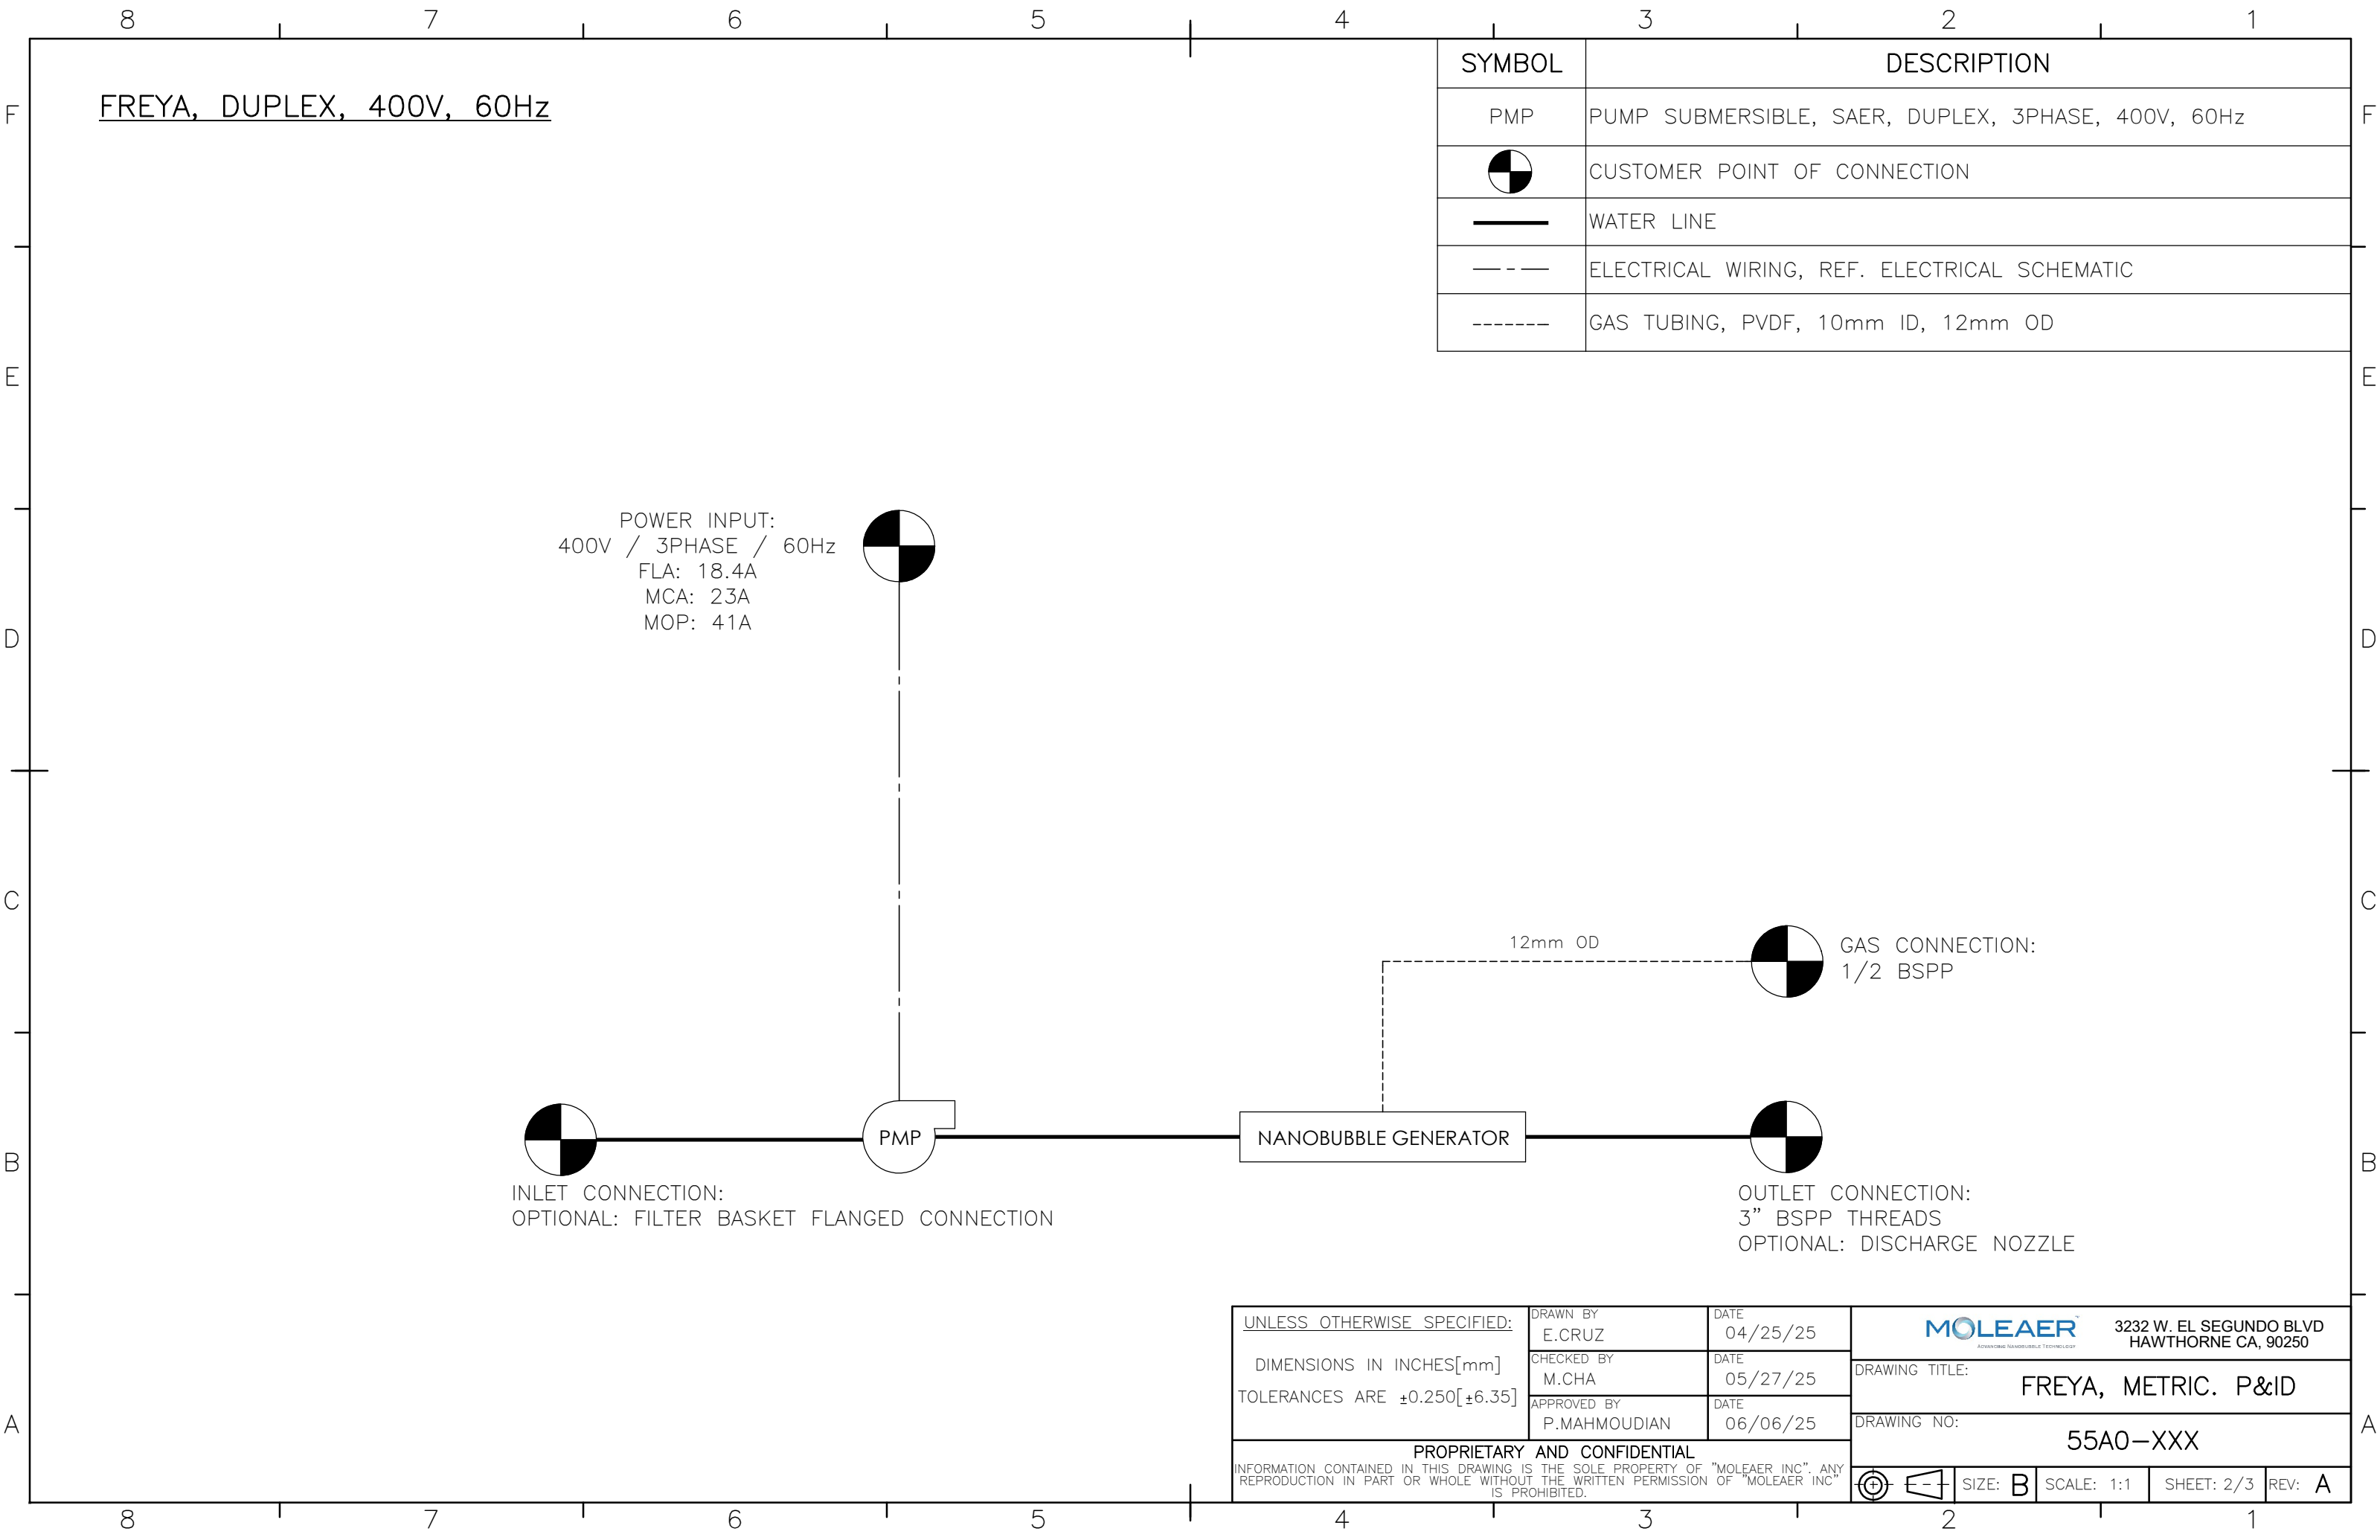
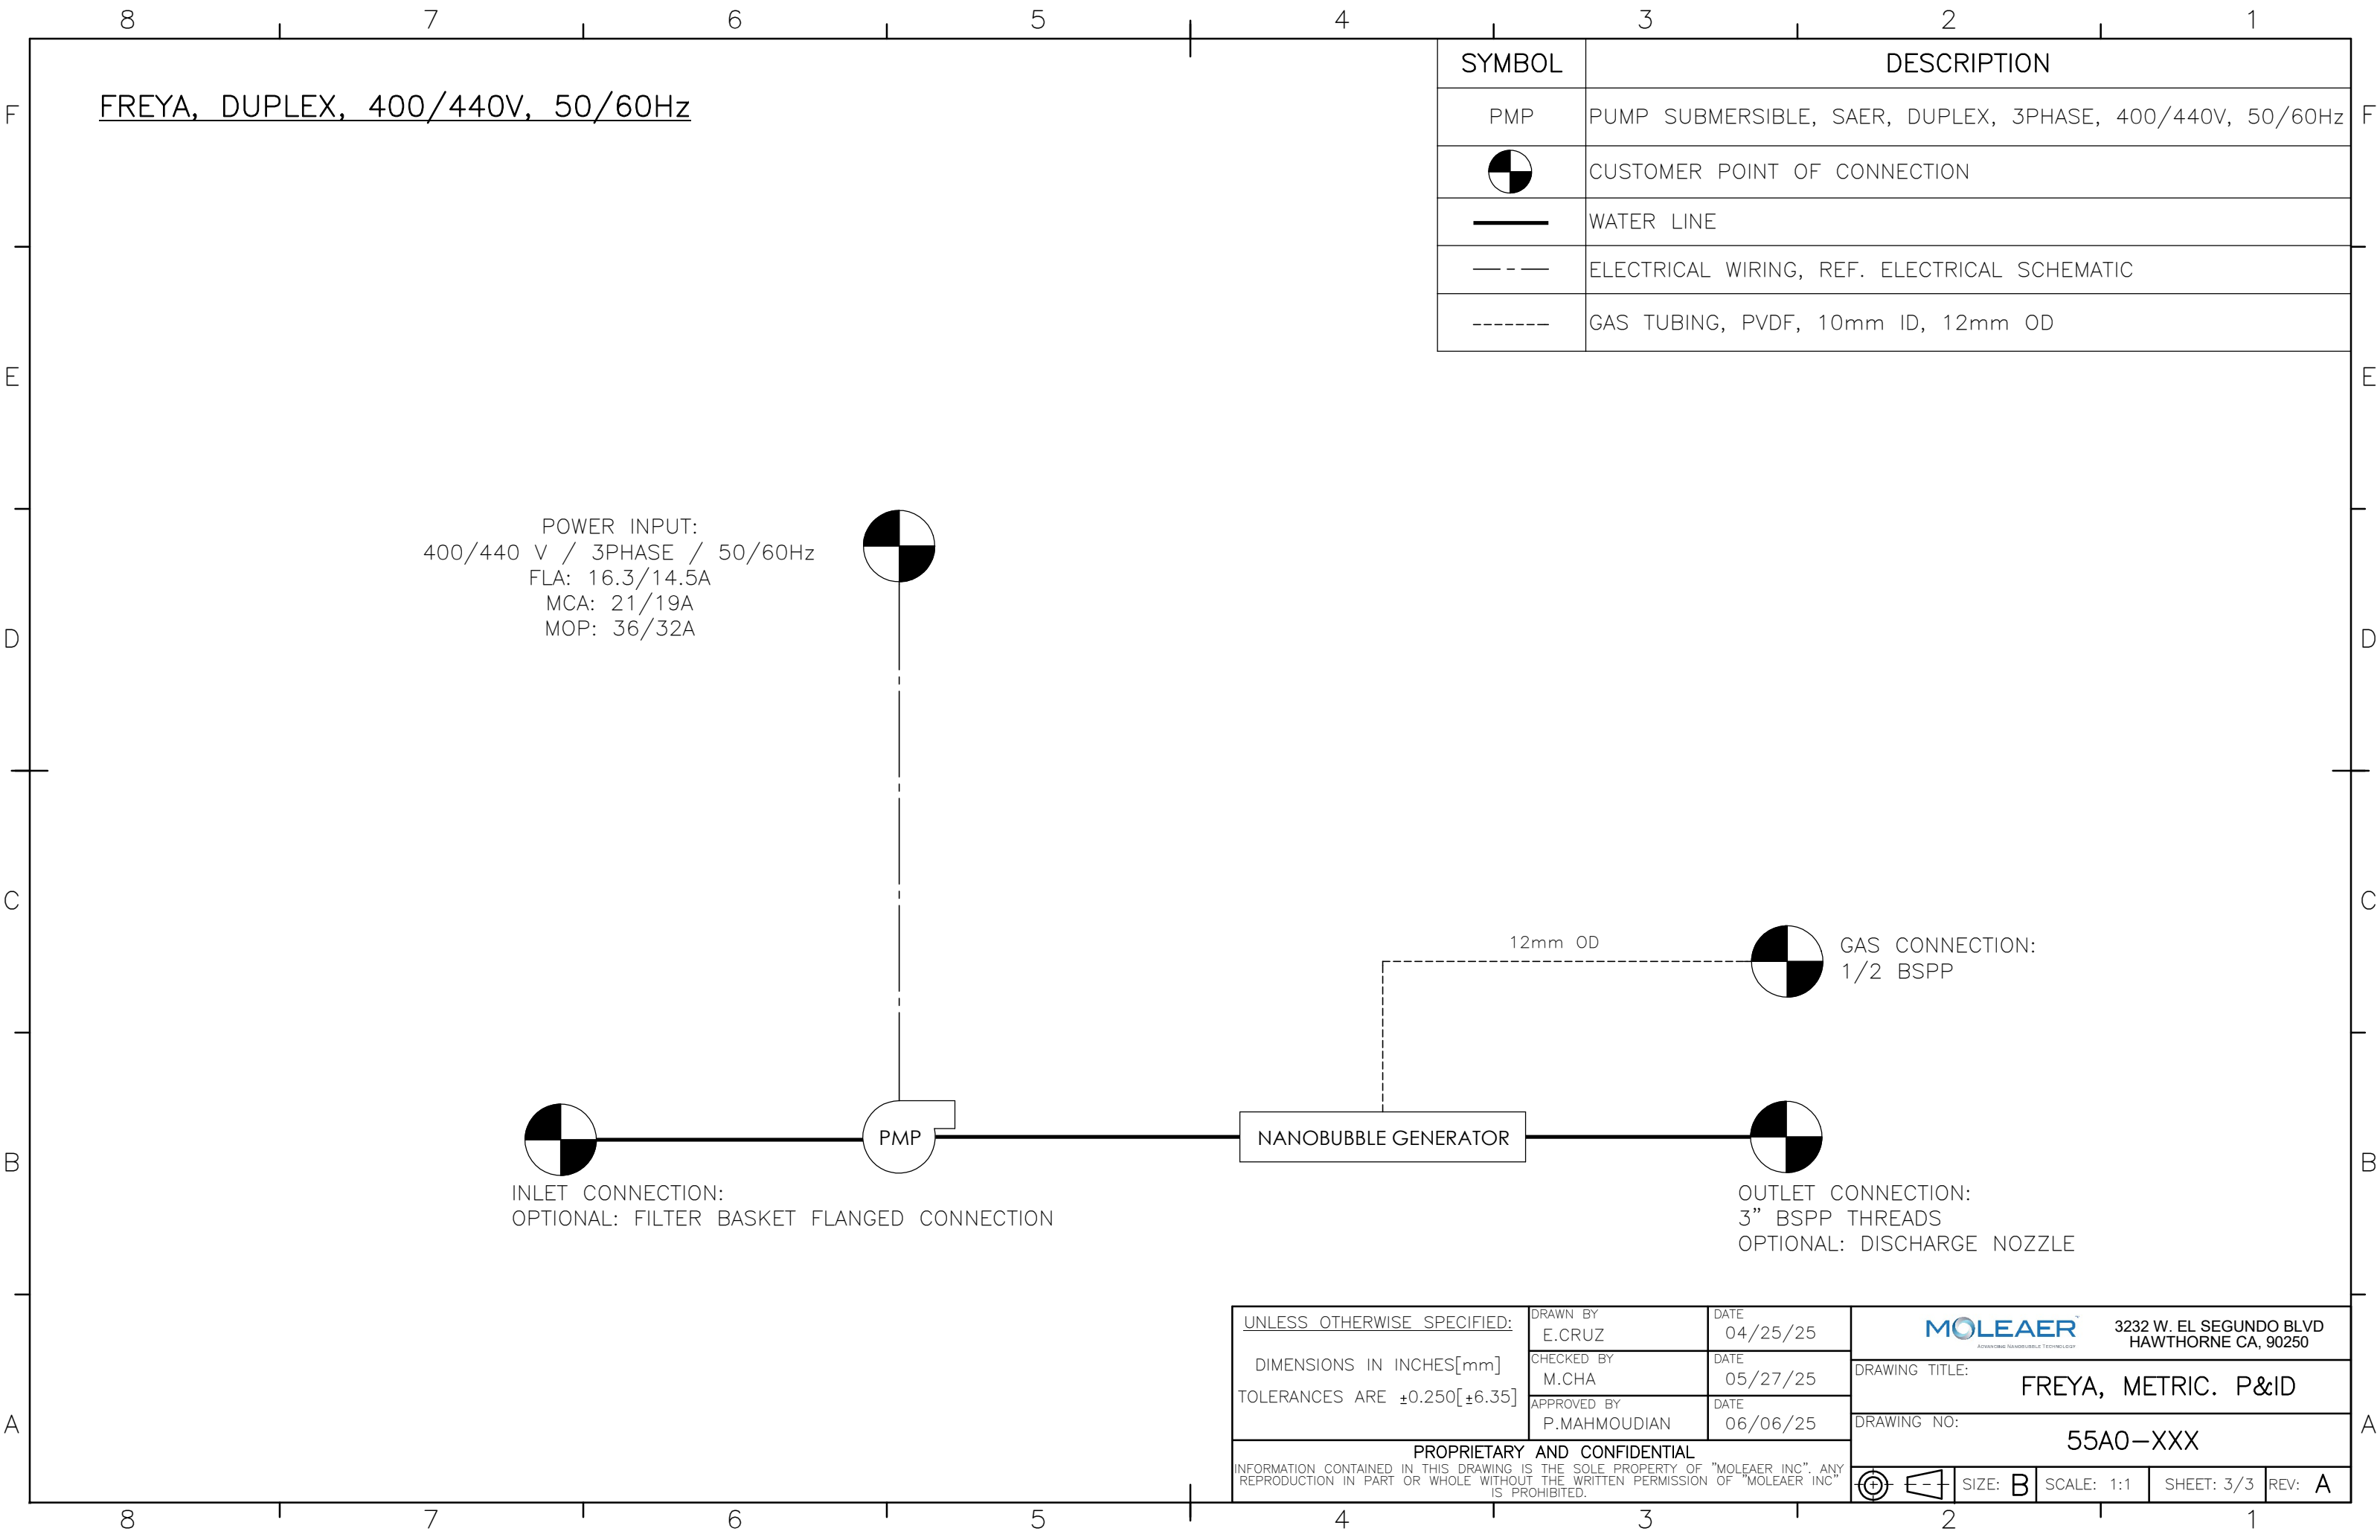




 

SYMBOL	DESCRIPTION
PMP	PUMP SUBMERSIBLE, SAER, 316SS, 3PHASE, 400/440V, 50/60Hz
	CUSTOMER POINT OF CONNECTION
	WATER LINE
	ELECTRICAL WIRING, REF. ELECTRICAL SCHEMATIC
	GAS TUBING, PVDF, 10mm ID, 12mm OD

A	EC	INITIAL RELEASE	2175	04/03/25	MC	PM
REV.	BY	DESCRIPTION	ECO	DATE	CHECKED	APPROVED
REVISIONS						

UNLESS OTHERWISE SPECIFIED: DIMENSIONS IN INCHES[mm] TOLERANCES ARE ±0.250[±6.35]	DRAWN BY E.CRUIZ	DATE 04/25/25	<div><div>MOLEAER</div><div>ADVANCING NANODISCUSS TECHNOLOGY</div></div> <div>3232 W. EL SEGUNDO BLVD HAWTHORNE CA, 90250</div>					
	CHECKED BY M.CHA	DATE 05/27/25	DRAWING TITLE: <div>FREYA, METRIC. P&ID</div>					
	APPROVED BY P.MAHMOUDIAN	DATE 06/06/25	DRAWING NO: <div>55A0-XXX</div>					
PROPRIETARY AND CONFIDENTIAL INFORMATION CONTAINED IN THIS DRAWING IS THE SOLE PROPERTY OF "MOLEAER INC". ANY REPRODUCTION IN PART OR WHOLE WITHOUT THE WRITTEN PERMISSION OF "MOLEAER INC" IS PROHIBITED.			<div><div><div><div><div></div></div></div><div><div></div></div></div><div>SIZE: B</div><div>SCALE: 1:1</div><div>SHEET: 1/3</div><div>REV: A</div></div>					





SYMBOL	DESCRIPTION
PMP	PUMP SUBMERSIBLE, SAER, DUPLEX, 3PHASE, 400/440V, 50/60Hz
	CUSTOMER POINT OF CONNECTION
	WATER LINE
	ELECTRICAL WIRING, REF. ELECTRICAL SCHEMATIC
	GAS TUBING, PVDF, 10mm ID, 12mm OD

<u>UNLESS OTHERWISE SPECIFIED:</u> DIMENSIONS IN INCHES[mm] TOLERANCES ARE ±0.250[±6.35]	DRAWN BY E.CRUIZ	DATE 04/25/25	<div><div>MOLEAER™ <small>ADVANCING NANOSCALE TECHNOLOGY</small></div><div>3232 W. EL SEGUNDO BLVD HAWTHORNE CA, 90250</div></div>					
	CHECKED BY M.CHA	DATE 05/27/25	DRAWING TITLE: FREYA, METRIC. P&ID					
	APPROVED BY P.MAHMOUDIAN	DATE 06/06/25	DRAWING NO: 55A0-XXX					
PROPRIETARY AND CONFIDENTIAL INFORMATION CONTAINED IN THIS DRAWING IS THE SOLE PROPERTY OF "MOLEAER INC". ANY REPRODUCTION IN PART OR WHOLE WITHOUT THE WRITTEN PERMISSION OF "MOLEAER INC" IS PROHIBITED.			<div><div><div><div><div><div></div></div></div><div><div><div></div></div></div></div><div><div><div></div></div></div><div><div><div></div></div></div></div><div>SIZE: B</div><div>SCALE: 1:1</div><div>SHEET: 3/3</div><div>REV: A</div></div>					